


PRELIMINARY DRAWING

Colour Schedule

External		
Cladding	-	Surfmist
Roof	-	Zincalume
Capping	-	Surfmist
Gutter	-	Surfmist
Downpipe	-	Surfmist
Doors	-	White
Windows	-	White

Internal		
Vinyl	-	Grey
Walls	-	Grey
Ceiling	-	White
Cabinetry	-	White

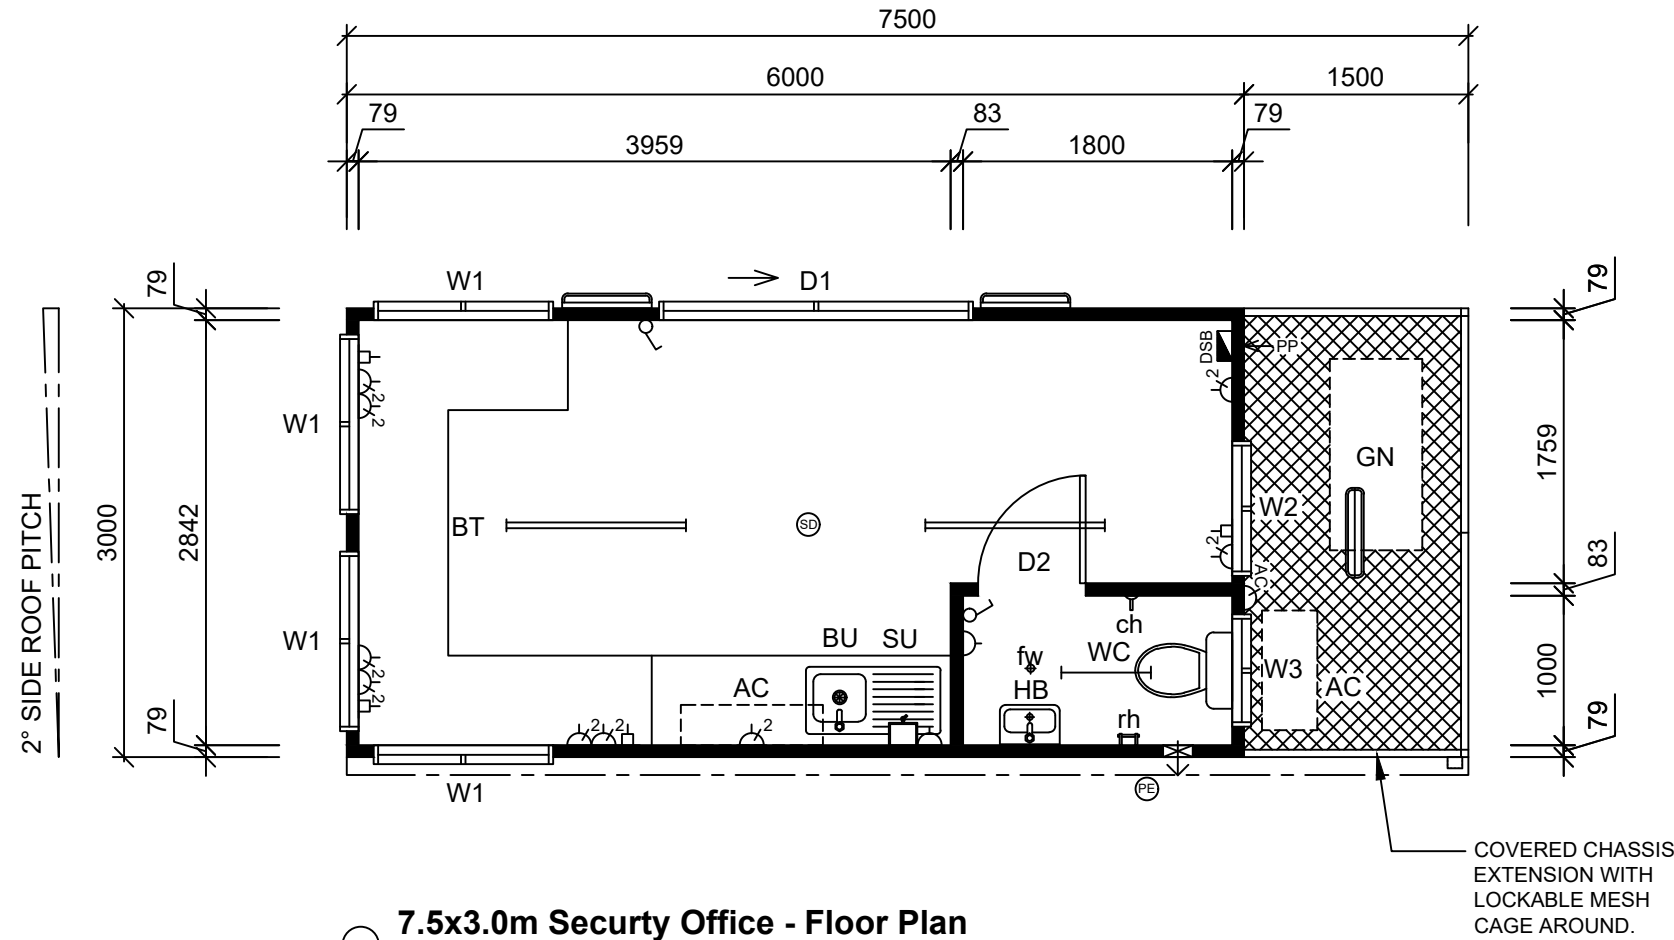

7.5x3.0m Security Office - Floor Plan

Scale 1:50

COVERED CHASSIS EXTENSION WITH LOCKABLE MESH CAGE AROUND.

CLIENT APPROVAL

Signature: _____ Date: _____

Rev.	Description	Date	By
A	Issued for Client Review	31/03/21	BW
B	Mirror Building Layout	23/04/21	BW
C	Add Generator, Chassis Extension	29/04/21	BW

Item List

Item	Qty	Description
D1	x(1)	2100x2100mm Sliding Glass Door With Flydoor.
D2	x(1)	2040x720mm Internal Painted Hollow Core Door With Privacy Set, Door Closer & Toilet Sign.
W1	x(4)	900x1200mm Sliding Glass Window With Flyscreen.
W2	x(1)	900x900mm Sliding Glass Window With Flyscreen.
W3	x(1)	300x750mm Sliding Obscure Glass Window With Flyscreen.
AC	x(1)	3.5kw Inverter Reverse Cycle Split System Air Conditioner. <i>*Note: External AC Units Mounted On Chassis Extension.</i>
SU	x(1)	2000mm Bench Top & Splashback, Set Of Drawers & Cupboards Under, Single Bowl Single Drainer Sink (Cold Only).
BT	x(1)	4900mm Laminated Bench Top With Legs Under.
BU	x(1)	3L Boiling Water Unit - Wall Mounted.
WC	x(1)	Toilet Pan With Dual Flush Cistern.
HB	x(1)	Wall Mounted Hand Basin (Cold) With Mirror Over.
rh	x(1)	Roll Holder.
ch	x(1)	Coat Hook.
fw	x(1)	Floor Waste.
GN	x(1)	Kuboota GL9000-AU-B, 9kVa Single Phase Diesel Generator, 28L Fuel Tank (*Approx. 8 Hours Run Time).

Notes

- 75mm Steel Frame Construction.
- 150x75mm PFC Bearers / C10015 Floor Joists @ 600mm Ctrs.
- 19mm T&G F11 Plywood Flooring.
- 2mm Commercial Vinyl Floor Covering.
- 2mm Slip Resistant Vinyl Floor Covering, Coved In Wet Areas.
- 2400mm Internal Ceiling Height.
- Horizontal 'Panelrib' Profile External Colorbond Cladding.
- Zincalume 'Trimdek' Profile Roof Sheeting.
- Pre-finished Plywood Internal Wall & Ceiling Lining With PVC Joiners, Cornice, Skirting & Corner Moulds.
- Wall & Ceiling Insulation.
- Gutters & Downpipes (*Packed For Site Installation).

Electrical Legend

Icon	Qty	Description
	x(1)	Internal Lockable Distribution Switchboard With Double Pole Main Switch, Double Pole Circuit Breakers & Light Test Point.
	x(1)	Plug In Electrical Point Of Entry
	x(2)	Light Switch (Double Pole)
	x(2)	10amp Single GPO (Double Pole)
	x(9)	10amp Double GPO (Double Pole)
	x(2)	External Isolator Switch - AC (Double Pole)
	x(4)	Draw Wire With Blank Plate
	x(2)	1200mm LED External Light Fitting.
	x(1)	600mm LED Internal Light Fitting.
	x(3)	600mm LED External Light Fitting.
	x(1)	Wall Mounted Exhaust Fan.
	x(1)	Smoke Detector.
	x(1)	PE Cell.



THIS DRAWING AND DESIGN IS THE SOLE PROPERTY OF JABEGIL PTY LTD T/A MULTITRADE BUILDING HIRE A.B.N. 36 010 138 600 IT MAY NOT BE REPRODUCED, COPIED WHOLE OR IN PART WITHOUT WRITTEN AUTHORITY.

CLIENT GLADSTONE PORTS CORPORATION LIMITED	DATE 29/04/21
TITLE 7.5x3.0m SECURITY OFFICE - FLOOR PLAN	SCALE 1:50
DESIGN WIND LOAD C2 (W50C)	DRAWN BW
CHECKED	
DRAWING NUMBER SQF-3830-01	REVISION C
	SHEET SIZE A3