


PRELIMINARY DRAWING

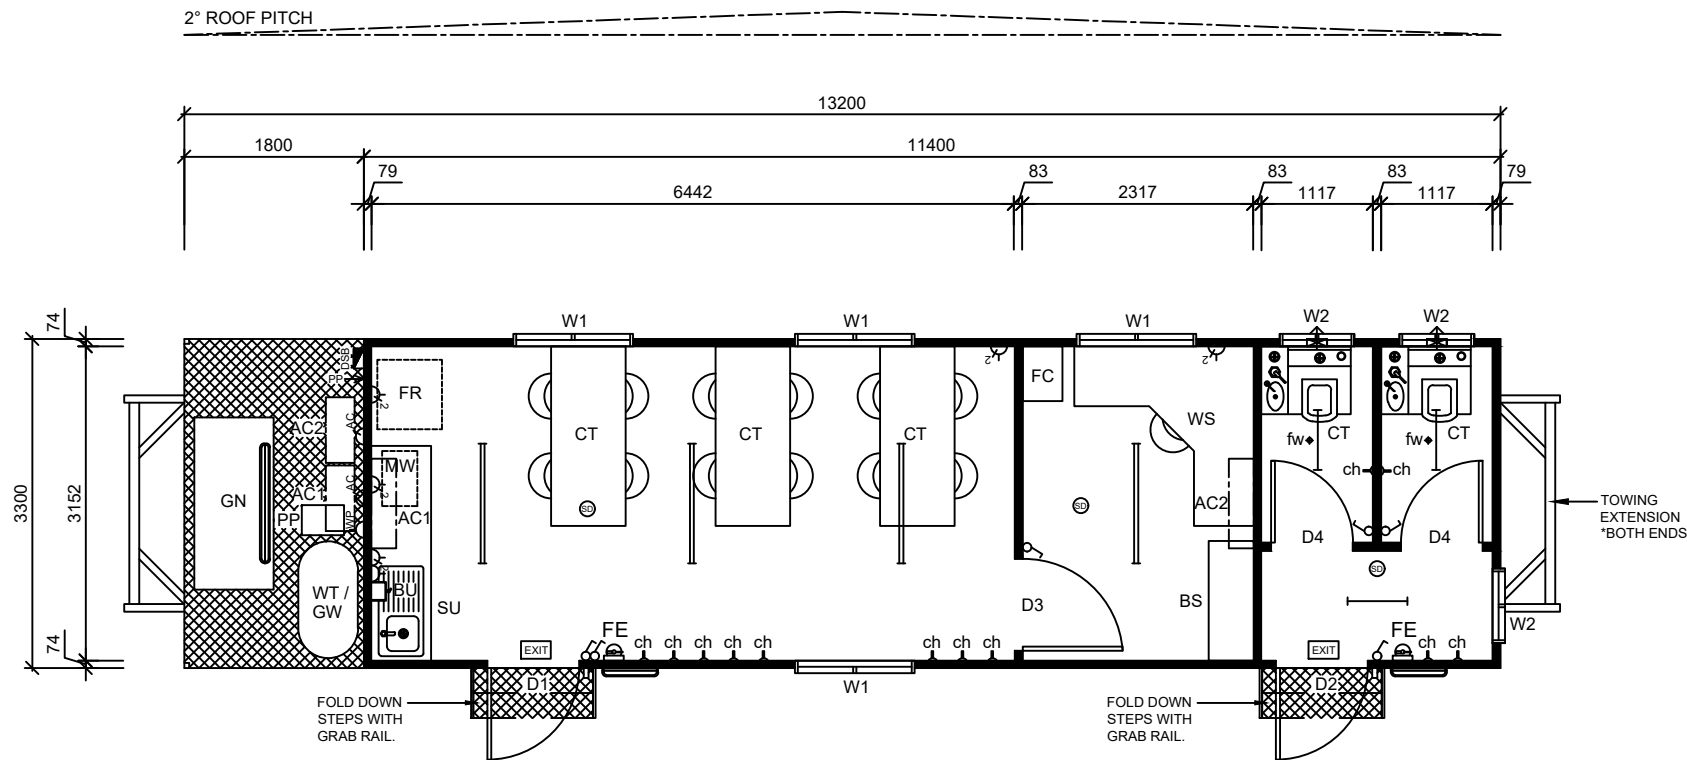

13.2x3.3m Site Building - Floor Plan

Scale 1:75

Item List

Item	Qty	Description
D1	x(1)	2040x920mm External Metal Clad Door With Glass Viewing Panel - Grey Glass, Lockset & Door Closer
D2	x(1)	2040x920mm External Metal Clad Door With Lockset, Door Closer, Door Vent & Toilet Sign.
D3	x(1)	2040x920mm Internal Painted Hollow Core Door With Lockset.
D4	x(2)	2040x820mm Internal Painted Hollow Core Door With Privacy Set, Door Closer & Toilet Sign.
W1	x(4)	900x1200mm Sliding Glass Window - Grey Glass, With Flyscreen & Holland Blind.
W2	x(3)	300x750mm Sliding Obscure Glass Window With Flyscreen.
AC1	x(1)	3.5kW Mitsubishi Heavy Industries Reverse Cycle Split System Air Conditioner, External Unit Mounted On Heavy Duty Bracket.
AC2	x(1)	2.5kW Mitsubishi Heavy Industries Reverse Cycle Split System Air Conditioner, External Unit Mounted On Heavy Duty Bracket.
GN	x(1)	15 kVa Kubota Mine Spec Single Phase Diesel Generator, Mounted On Covered Chassis Extension.
WT	x(1)	450 Ltr Potable Water Tank, On Metal Frame Over 'GW'
GW	x(1)	450 Ltr Grey Water Waste Tank.
PP	x(1)	Water Pressure Pump.
SU	x(1)	2000mm Bench Top & Splashback, Single Drawer & Cupboards Under, Single Bowl Single Drainer Sink (Cold Only).
BU	x(1)	3L Boiling Water Unit - Wall Mounted.

Item List (Cont.)

Item	Qty	Description
FR	x(1)	Approx. 450L All Fridge.
MW	x(1)	Approx. 25L Microwave.
CT	x(3)	Crib Table With (4)x Stack Chairs.
WS	x(1)	1800x1800mm Workstation With Drawers & Office Chair.
BS	x(1)	1200x730x450mm Lockable Credenza.
FC	x(1)	3 Drawer Filing Cabinet.
FE	x(2)	Fire Extinguisher.
CT	x(2)	Formit MFT3 - Chemical Toilet With Built In Hand Basin.
ch	x(12)	Coat Hooks.

Notes

- 75mm Steel Frame Construction.
- 410UB53 Chassis Bearers With Towing Extensions - Both Ends Of Chassis / C10015 Floor Joists @ 400mm Ctrs.
- 19mm T&G F11 Plywood Flooring.
- Commercial 2mm Vinyl Floor Covering, Coved 150mm Up Walls.
- Commercial R10 Slip Resistant Vinyl, Coved 150mm Up Walls.
- 2400mm Internal Ceiling Height.
- Pre-finished Plywood Internal Wall & Ceiling Linings With PVC Joiners, Cornice & Corners Throughout.
- Wall & Ceiling Insulation.
- Horizontal 'Panelrib' Profile External Colorbond Cladding.
- Zincalume 'Trimdek' Profile Roof Sheeting.

Electrical Legend

Icon	Qty	Description
	x(1)	Metal Distribution Switchboard (Lockable), Single Phase With Double Pole 10kA Rated Main Switch, Double Pole 10kA Rated Circuit Breakers With Cirlock Metal Lockouts, Emergency Light Kit & Test Points.
	x(1)	32 Amp Single Phase Plug In Electrical Point Of Entry.
	x(6)	Light Switch (Double Pole).
	x(1)	10amp Single GPO (Double Pole).
	x(5)	10amp Double GPO (Double Pole).
	x(1)	10amp Single Weatherproof GPO (Double Pole).
	x(2)	External Isolator Switch - Split AC.
	x(4)	1200mm LED Internal Light Fitting.
	x(3)	600mm LED Internal Light Fitting.
	x(1)	1200mm LED External Light Fitting.
	x(2)	600mm LED External Light Fitting.
	x(3)	Smoke Detector.
	x(2)	Emergency Exit Light.

Colour Schedule

External		
Cladding	-	Surfmist
Roof	-	Zincalume
Flashings	-	Surfmist
Capping	-	Surfmist
Doors	-	White
Windows	-	White

Internal		
Vinyl	-	Grey
Vinyl (R10)	-	Grey
Walls	-	Grey
Ceiling	-	White
Door	-	Grey
Cabinetry	-	Grey

CLIENT APPROVAL

Signature: \_\_\_\_\_ Date: \_\_\_\_\_

Rev.	Description	Date	By
A	Issued For Client Review	02/07/21	BW



THIS DRAWING AND DESIGN IS THE SOLE PROPERTY OF JABEGIL PTY LTD T/A MULTITRADE BUILDING HIRE A.B.N. 36 010 138 600 IT MAY NOT BE REPRODUCED, COPIED WHOLE OR IN PART WITHOUT WRITTEN AUTHORITY.

CLIENT		DATE
		02/07/21
TITLE		SCALE
13.2x3.3m SITE BUILDING - FLOOR PLAN		1:75
DESIGN WIND LOAD	DRAWN	CHECKED
C2 (W50C)	BW	
DRAWING NUMBER	REVISION	SHEET SIZE
SQF-3854-01	A	A3