

1381

Colour Schedule

- External
- Cladding - Colorbond
- Roof - Zincalume
- Flashings - Colorbond
- Capping - Colorbond
- Gutter - Colorbond
- Downpipe - Colorbond
- Doors - White
- Windows - White

- Internal
- Vinyl (R10) - Grey
- Walls - Grey
- Ceiling - Mirage Pearl

CLIENT APPROVAL

Signature: _____ Date: _____


Rev.	Description	Date	By
A	Issued for Client Review	31/01/13	BL



MULTITRADE
 6 SOUTH TREES DRIVE
 PO BOX 642
 GLADSTONE
 4680, QLD, AUSTRALIA
 Phone: 07 4979 2333
 Fax: 07 4979 1698
 Email: multitrade@hotmail.net.au
 www.multitrade.com.au

THIS DRAWING AND DESIGN IS THE SOLE PROPERTY OF IAREGIL PTY LTD. T/A MULTITRADE BUILDING HIRE. A.B.N. 36 010 138 600. IT MAY NOT BE REPRODUCED, COPIED WHOLE OR IN PART WITHOUT WRITTEN AUTHORITY.

CLIENT	DATE
DOWNER EDI RAIL	31/01/13
TITLE	SCALE
6.0x2.4m TOILET / SHOWER BLOCK	1:50
DESIGN WIND LOAD	CHECKED
C2 - CYCLONIC	BL
DRAWING NUMBER	REVISION
SQF-1458-03	A
	SHEET SIZE
	A3

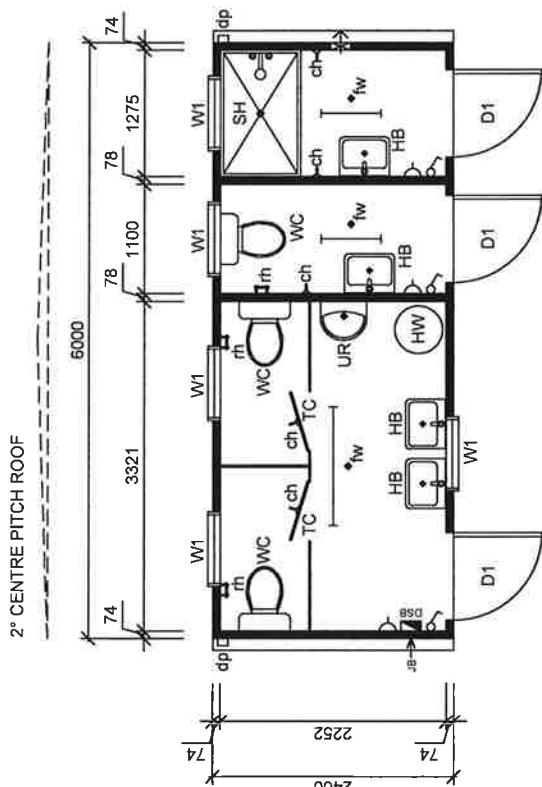

6.0x2.4m Toilet / Shower Block - Floor Plan
 Scale 1:50

Item List

Item	Qty	Description
D1	x(3)	2040x880mm External Metal Clad Door With Door Closer
W1	x(5)	300x750mm Fixed Obscure Glass Vented Window
SH	x(1)	Fibreglass Shower Base With PVC Curtain
HB	x(4)	Stainless Steel Hand Basin (Hot & Cold) With Mirror Over
WC	x(3)	Toilet Pan With Dual Flush Cistern
TC	x(2)	Toilet Cubicle With Door
UR	x(1)	Waterless Urinal
HW	x(1)	80 Ltr Hot Water System
rh	x(3)	Roll Holder
ch	x(5)	Coat Hook
fw	x(3)	Floor Waste
dp	x(2)	100x75mm Downpipe

Electrical Legend

Icon	Qty	Description
DBB	x(1)	Distribution Switchboard
←-JB	x(1)	Junction Box - Electrical Point Of Entry
⚡	x(3)	Light Switch
⚡	x(3)	10amp Single GPO
—	x(1)	36 Watt Single Fluorescent Light
—	x(2)	18 Watt Single Fluorescent Light
↻	x(1)	Wall Mounted Exhaust Fan

Notes

- Built To Multitrade Building Hire Specification
- 2400mm Internal Ceiling Height
- Covered R10 Slip Resistant Vinyl Throughout
- Plumbing To Be Harnesses To Single Connection Point
- Gutters & Downpipe