


# PRELIMINARY DRAWING

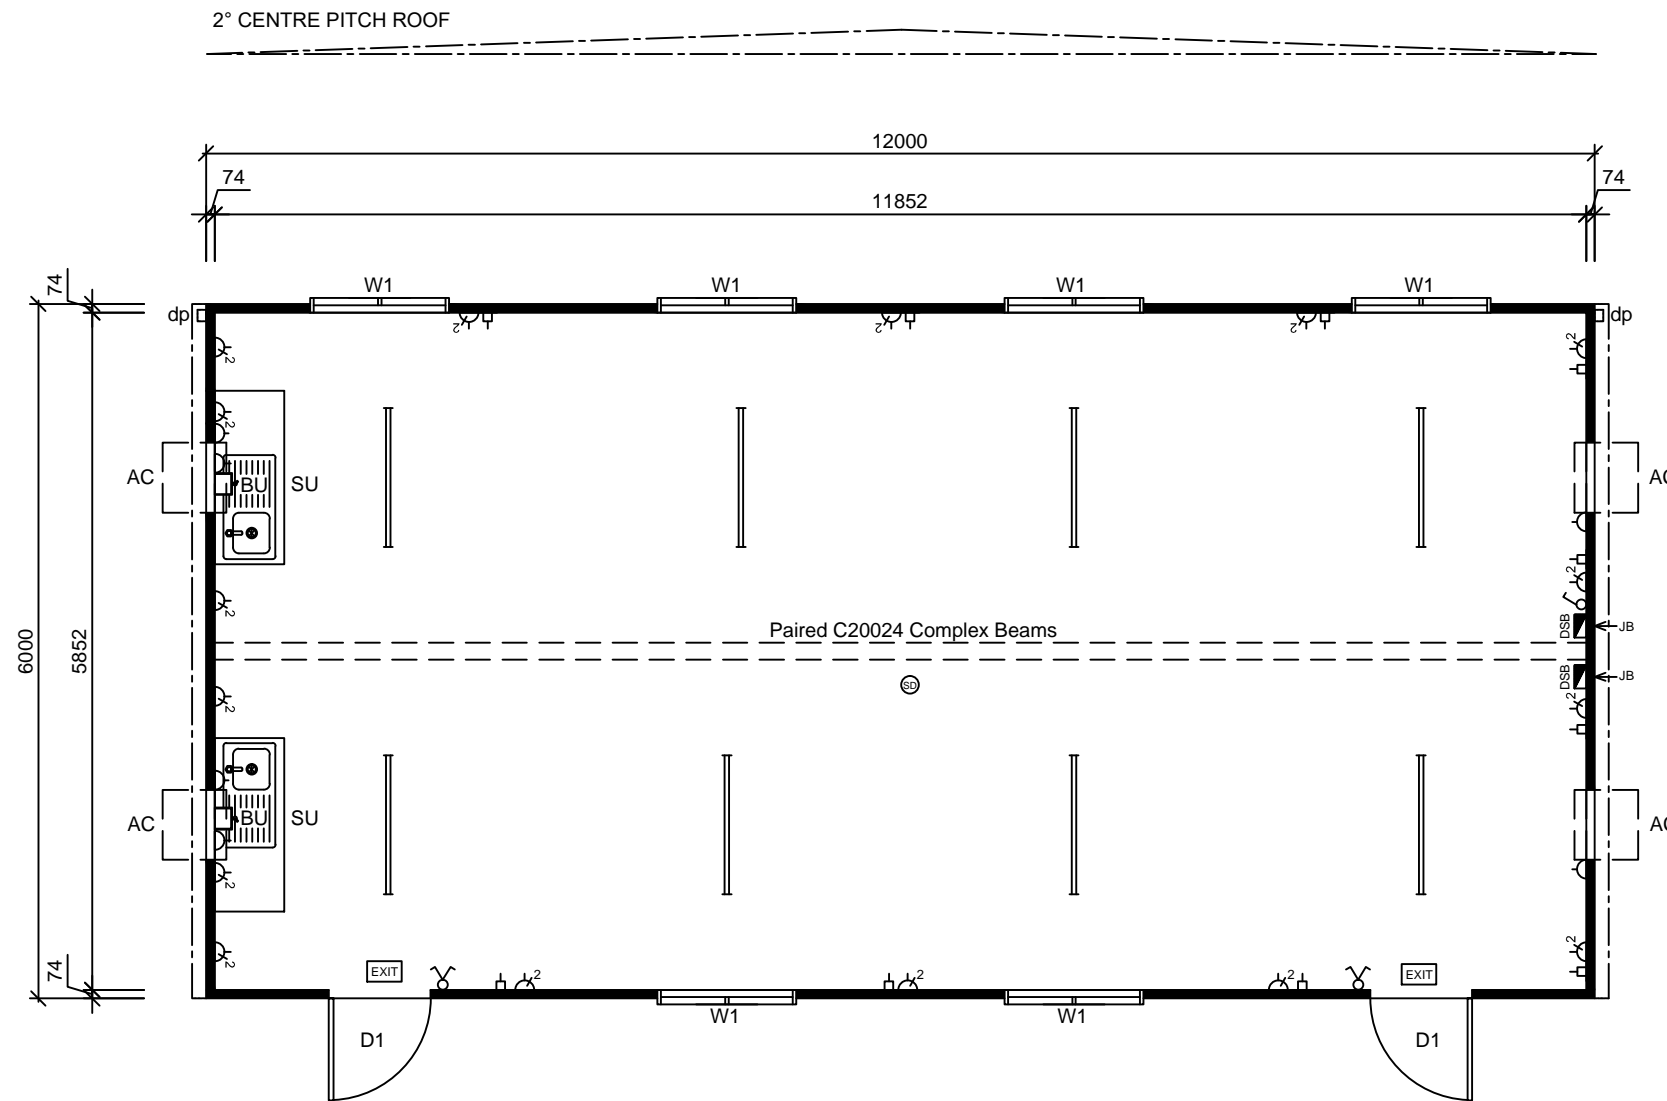

**12.0x6.0m Crib Room - Floor Plan**

Scale 1:50

## Colour Schedule

External	
Cladding	- Surfmist
Roof	- Zinalume
Capping	- Surfmist
Gutter	- Surfmist
Downpipe	- Surfmist
Doors	- White
Windows	- White
Internal	
Vinyl	- Grey
Walls	- Grey
Ceiling	- White
Beams	- Grey
Cabinetry	- White

## Item List

Item	Qty	Description
D1	x(2)	2040x920mm External Metal Clad Door With Glass Viewing Panel & Door Closer.
W1	x(6)	900x1200mm Sliding Glass Window (Grey Glass) With Flyscreen.
AC	x(4)	Provision For Wall Mounted Air Conditioner.
SU	x(2)	1500mm Bench Top With Splashbacks, Cupboards & Single Drawer Under, Single Bowl Single Drainer Sink (Cold).
BU	x(2)	Boiling Water Unit - Wall Mounted.
dp	x(2)	100x75mm Downpipe

## Notes

- Built To Multitrade Hire Specifications
- 150x75mm Bearers / C10015 Floor Joists @ 600mm Ctrs.
- 19mm T&G F11 Plywood Flooring.
- 2mm Commercial Vinyl Floor Covering.
- 2400mm Internal Ceiling Height.
- Horizontal 'Panelrib' Profile External Colorbond Cladding.
- Zinalume 'Trimdek' Profile Roof Sheeting.
- Pre-finished Plywood Internal Wall & Ceiling Linings With PVC Joiners, Skirting, Cornice & Corners Throughout.
- Wall & Ceiling Insulation.
- Gutters & Downpipes (Packed For Site Installation).

## Electrical Legend

Icon	Qty	Description
	x(2)	Distribution Switchboard (Internal)
	x(2)	Junction Box - Electrical Point Of Entry
	x(2)	Two Way Light Switch
	x(2)	Light Switch
	x(6)	10amp Single GPO
	x(16)	10amp Double GPO
	x(10)	Draw Wire With Blank Plate
	x(8)	40 Watt LED 1200mm Batten Light Fitting (*Diffuser To Be Zip Tied).
	x(2)	Emergency Exit Light
	x(1)	Smoke Detector.

## CLIENT APPROVAL

Signature: \_\_\_\_\_ Date: \_\_\_\_\_

Rev.	Description	Date	By
A	Issued for Client Review	03/04/18	BW



THIS DRAWING AND DESIGN IS THE SOLE PROPERTY OF JABEGIL PTY LTD T/A MULTITRADE BUILDING HIRE A.B.N. 36 010 138 600 IT MAY NOT BE REPRODUCED, COPIED WHOLE OR IN PART WITHOUT WRITTEN AUTHORITY.

CLIENT	DATE	
<b>GOLDING (BARALABA)</b>	<b>03/04/18</b>	
TITLE	SCALE	
<b>12.0x6.0m CRIB ROOM</b>	<b>1:75</b>	
DESIGN WIND LOAD	DRAWN	CHECKED
<b>C2 (W50C)</b>	<b>BW</b>	
DRAWING NUMBER	REVISION	SHEET SIZE
<b>SQF-3222-03</b>	<b>A</b>	<b>A3</b>