


# Colour Schedule

- External
- Cladding - Surfmist
  - Roof - Zincalume
  - Flashings - Surfmist
  - Capping - Surfmist
  - Door - Surfmist
  - Windows - White

- Internal
- Vinyl - Grey
  - Walls - Grey
  - Ceiling - Mirage Pearl

2° CENTRE PITCH ROOF

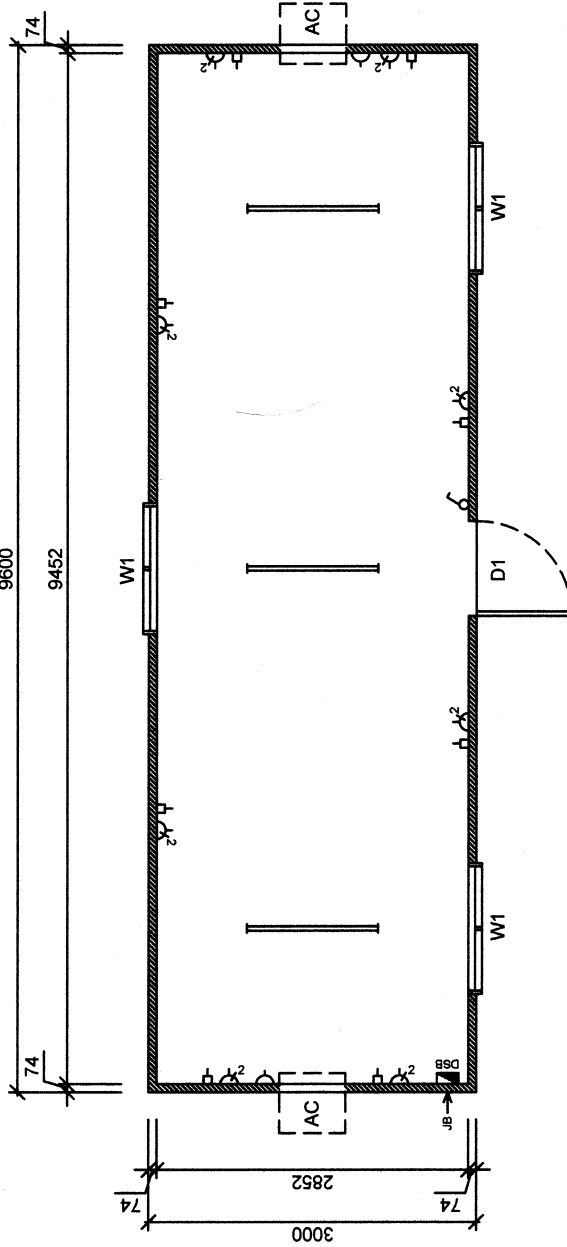

**9.6x3.0m Office - Floor Plan**

Scale 1:50

## Item List

Item	Qty	Description
D1	x(1)	2040x850mm External Metal Clad Door
W1	x(3)	900x1200mm Sliding Glass Window - Grey Glass
AC	x(2)	Frame & Cutout Only - For Wall Mounted Air Conditioner (Cutout Size - 605mm Wide x 385mm High)

## Notes

- Built to Multitrade Building Hire Specification
- 2400mm Internal Ceiling Height

## Electrical Legend

Icon	Qty	Description
	x(1)	Distribution Switchboard
	x(1)	Junction Box - Electrical Point Of Entry
	x(1)	Light Switch
	x(2)	10amp Single GPO
	x(8)	10amp Double GPO
	x(8)	Draw Wire With Blank Plate
	x(3)	36 Watt Double Fluorescent Light

Signature: \_\_\_\_\_ Date: \_\_\_\_\_

Rev.	Description	Date	By
A	Issued for Approval	24/01/11	B1



**MULTITRADE**  
 6 SOUTH TREES DRIVE  
 PO BOX 8005  
 SOUTH GLADSTONE  
 4680, QLD, AUSTRALIA

Phone: 07 4979 2333  
 Fax: 07 4979 1698  
 Email: multitrade@hotmail.com.au

www.multitrade.com.au

THIS DRAWING AND DESIGN IS THE SOLE PROPERTY OF  
 HALBIMBU PTY LTD T/A MULTITRADE A.B.N. 40 033 426 884  
 IT MAY NOT BE REPRODUCED, COPIED WHOLE OR IN PART  
 WITHOUT WRITTEN AUTHORITY.

CLIENT	DATE	SCALE	CHECKED
9.6x3.0m OFFICE	24/01/11	1:50	CHECKED
DESIGN WIND LOAD			
C2 - CYCLONIC	B1		
DRAWING NUMBER		REVISION	
MBH-9630-OFF-01	A		
SHEET SIZE			
A3			