

Colour Schedule

<u>External</u>	Surfmist
Cladding	-
Roof	Zincalume
Flashings	Surfmist
Capping	Surfmist
Door	Surfmist
Window	White
<u>Internal</u>	
Vinyl	Grey
Walls	Grey
Ceiling	Mirage Pearl
Cabinetry	White

CLIENT APPROVAL

Signature: _____

Date: _____

Rev.	Description	Date	By
A	Issued for Approval	24/01/11	B1




MULTITRADE
6 SOUTH TREES DRIVE
PO BOX 8005
SOUTH GLADSTONE
4680, QLD, AUSTRALIA

Phone: 07 4979 2333
Fax: 07 4979 1698
Email: multitrade@hotkey.net.au

www.multitrade.com.au

THIS DRAWING AND DESIGN IS THE SOLE PROPERTY OF
HALBIMBU PTY LTD T/A MULTITRADE A.B.N. 40 033 426 884
IT MAY NOT BE REPRODUCED, COPIED WHOLE OR IN PART
WITHOUT WRITTEN AUTHORITY.

CLIENT	DATE
TITLE	SCALE
9.6x3.0m CRIBROOM	1:50
DESIGN WIND LOAD	CHECKED
C2 - CYCLONIC	DRAWN
DRAWING NUMBER	REVISION
MBH-9630-CRB-01	A
	SHEET SIZE
	A3

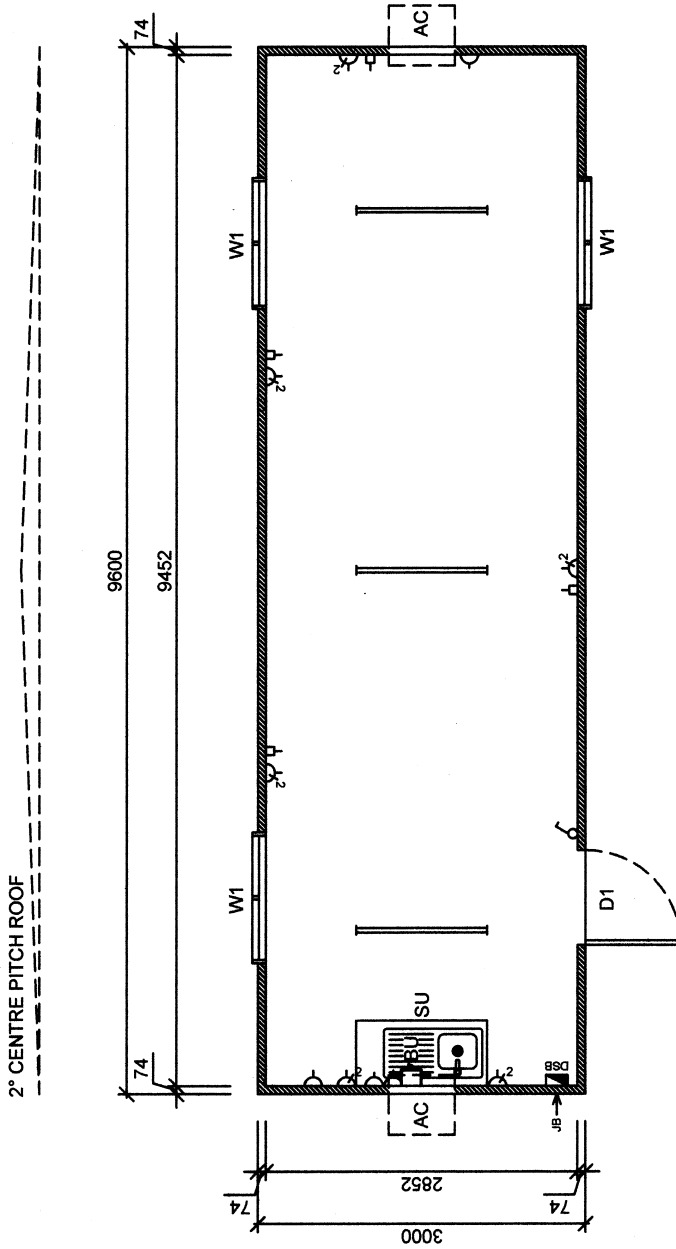

9.6x3.0m Cribroom - Floor Plan

Scale 1:50

Item List

Item	Qty	Description
D1	x(1)	2040x850mm External Metal Clad Door
W1	x(3)	900x1200mm Sliding Glass Window - Grey Glass
AC	x(2)	Frame & Cutout Only - For Wall Mounted Air Conditioner (Cutout Size - 605mm Wide x 385mm High)
SU	x(1)	1200mm Bench Top & Splashback, Cupboards Under, Single Bowl Single Drainer Sink (Cold Only)
BU	x(1)	Boiling Water Unit - Wall Mounted

Notes

- Built to Multitrade Building Hire Specification
- 2400mm Internal Ceiling Height

Electrical Legend

Icon	Qty	Description
	x(1)	Distribution Switchboard
	x(1)	Junction Box - Electrical Point Of Entry
	x(1)	Light Switch
	x(4)	10amp Single GPO
	x(6)	10amp Double GPO
	x(4)	Draw Wire With Blank Plate
	x(3)	36 Watt Double Fluorescent Light